




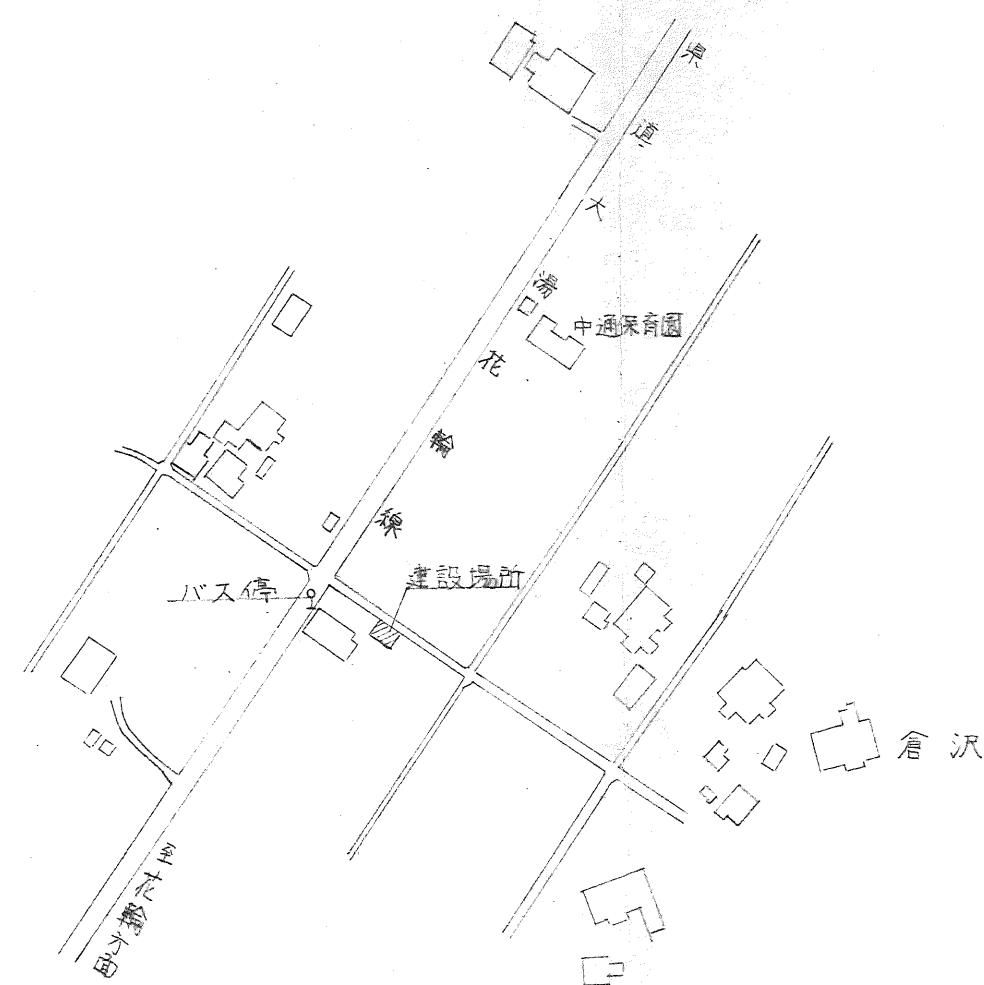


附近見取図

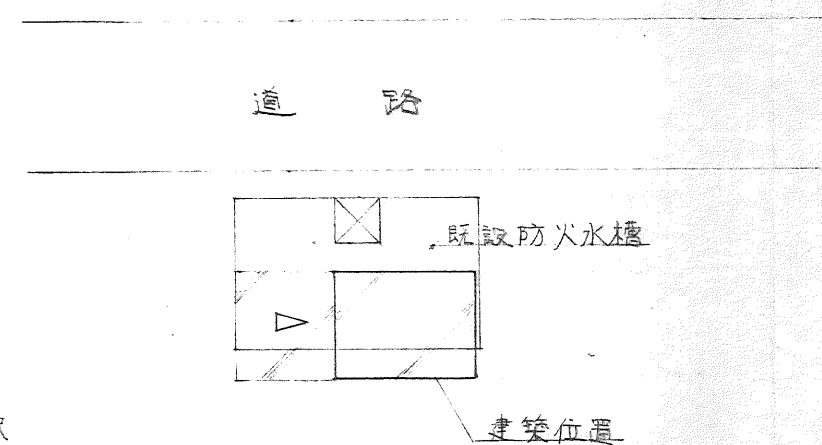


配置図 1/200

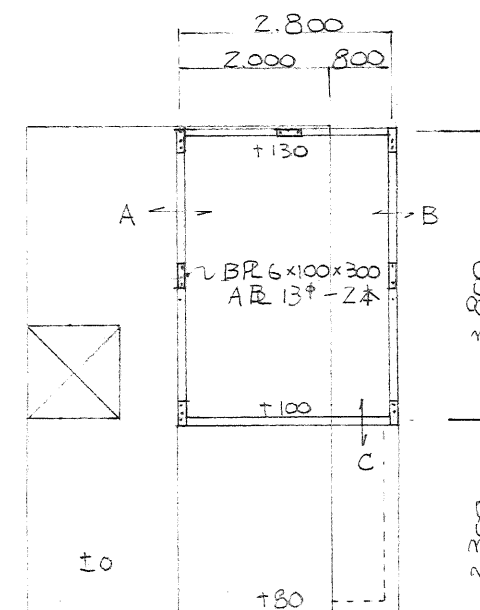


基礎伏図 1/100

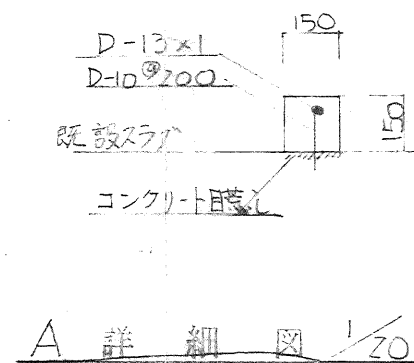


A 詳細図 1/20

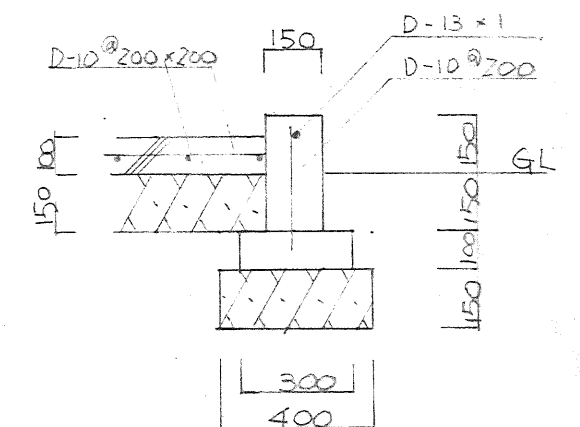


B 詳細図 1/20

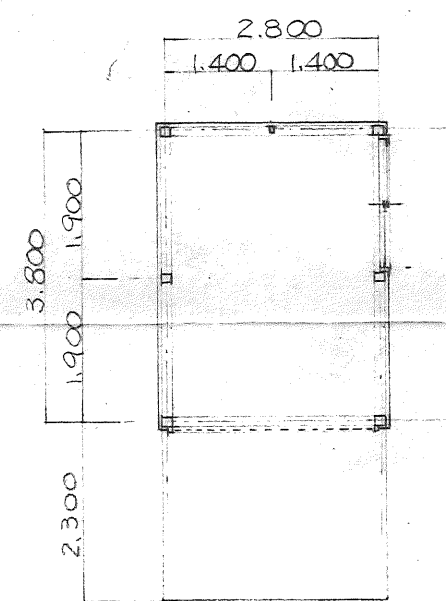


平面図 1/100
10.64㎡

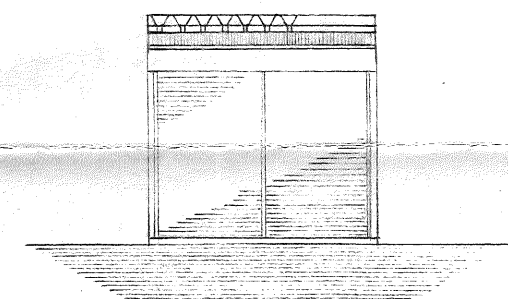


立面図 1/100

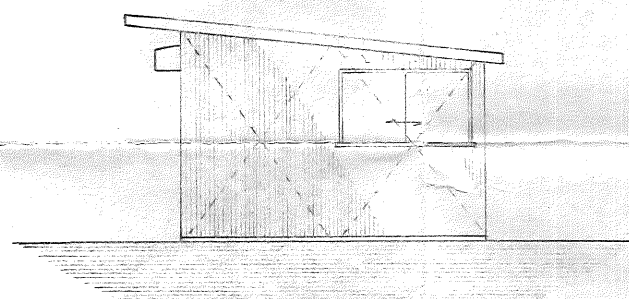


立面図 1/100

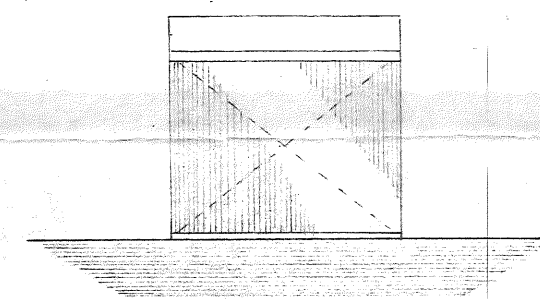


立面図 1/100

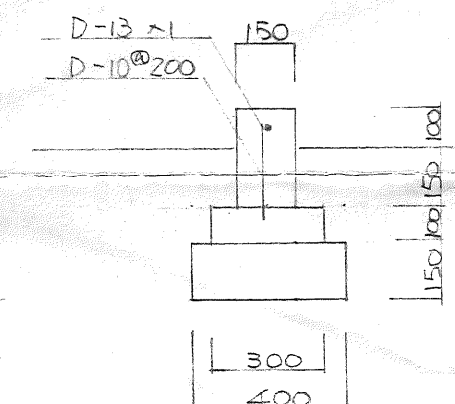


C 詳細図 1/20

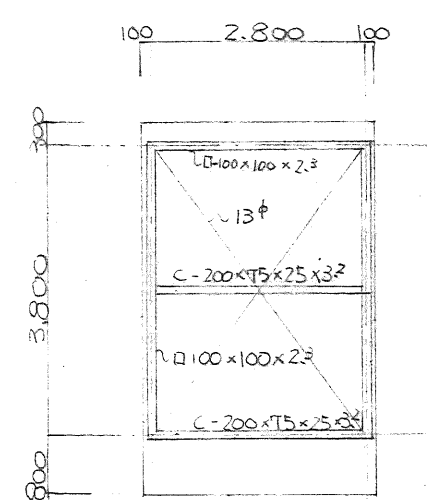

小屋伏図 1/100

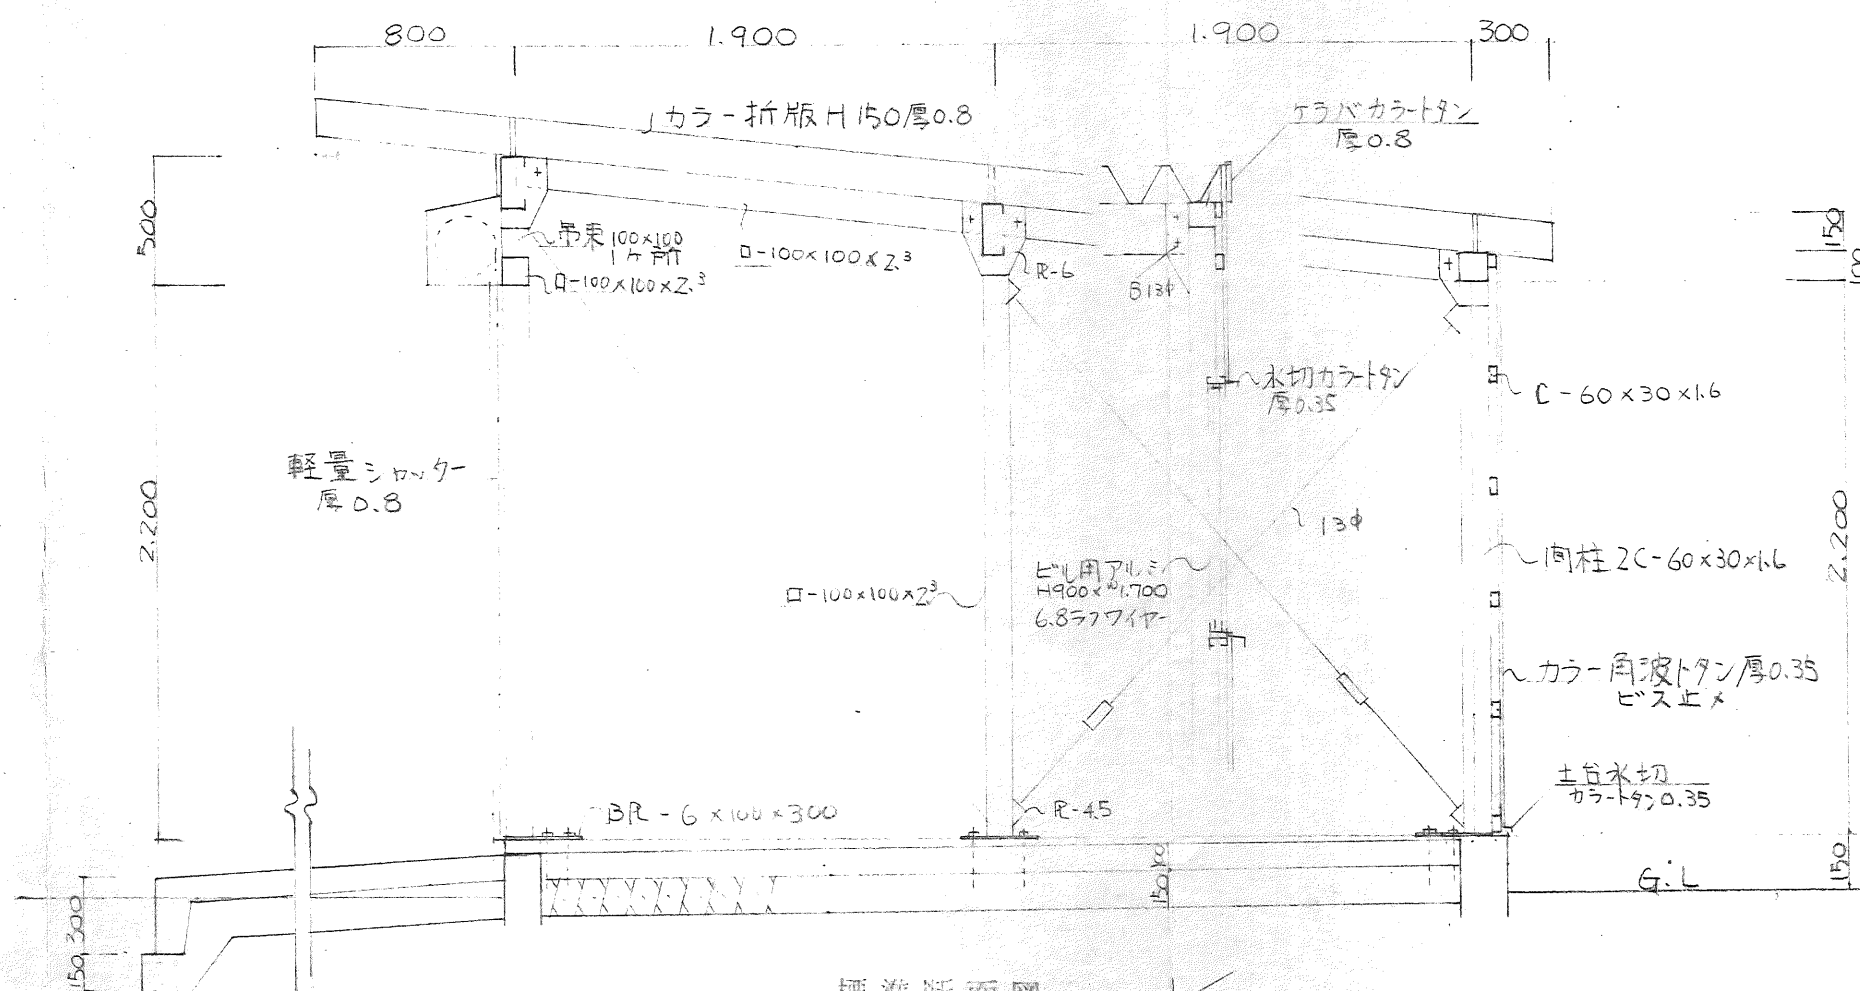

標準断面図 1/30

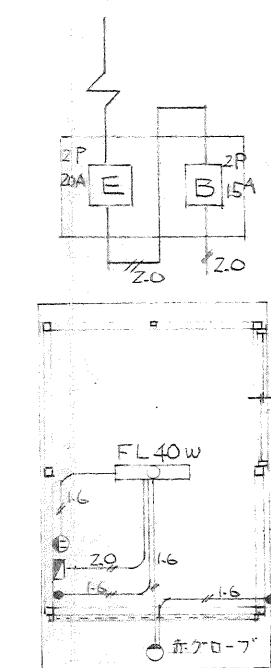

電気設備図 1/100

倉沢器具置場 参考図

工事名	風張消防器具置場新設工事		
図名			
縮尺		図番	
施設計画所建一課			

